
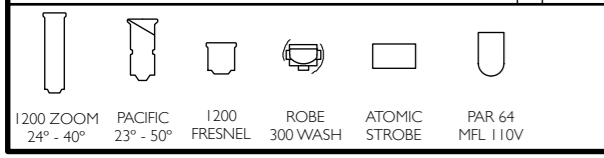


TRUSS TOWER

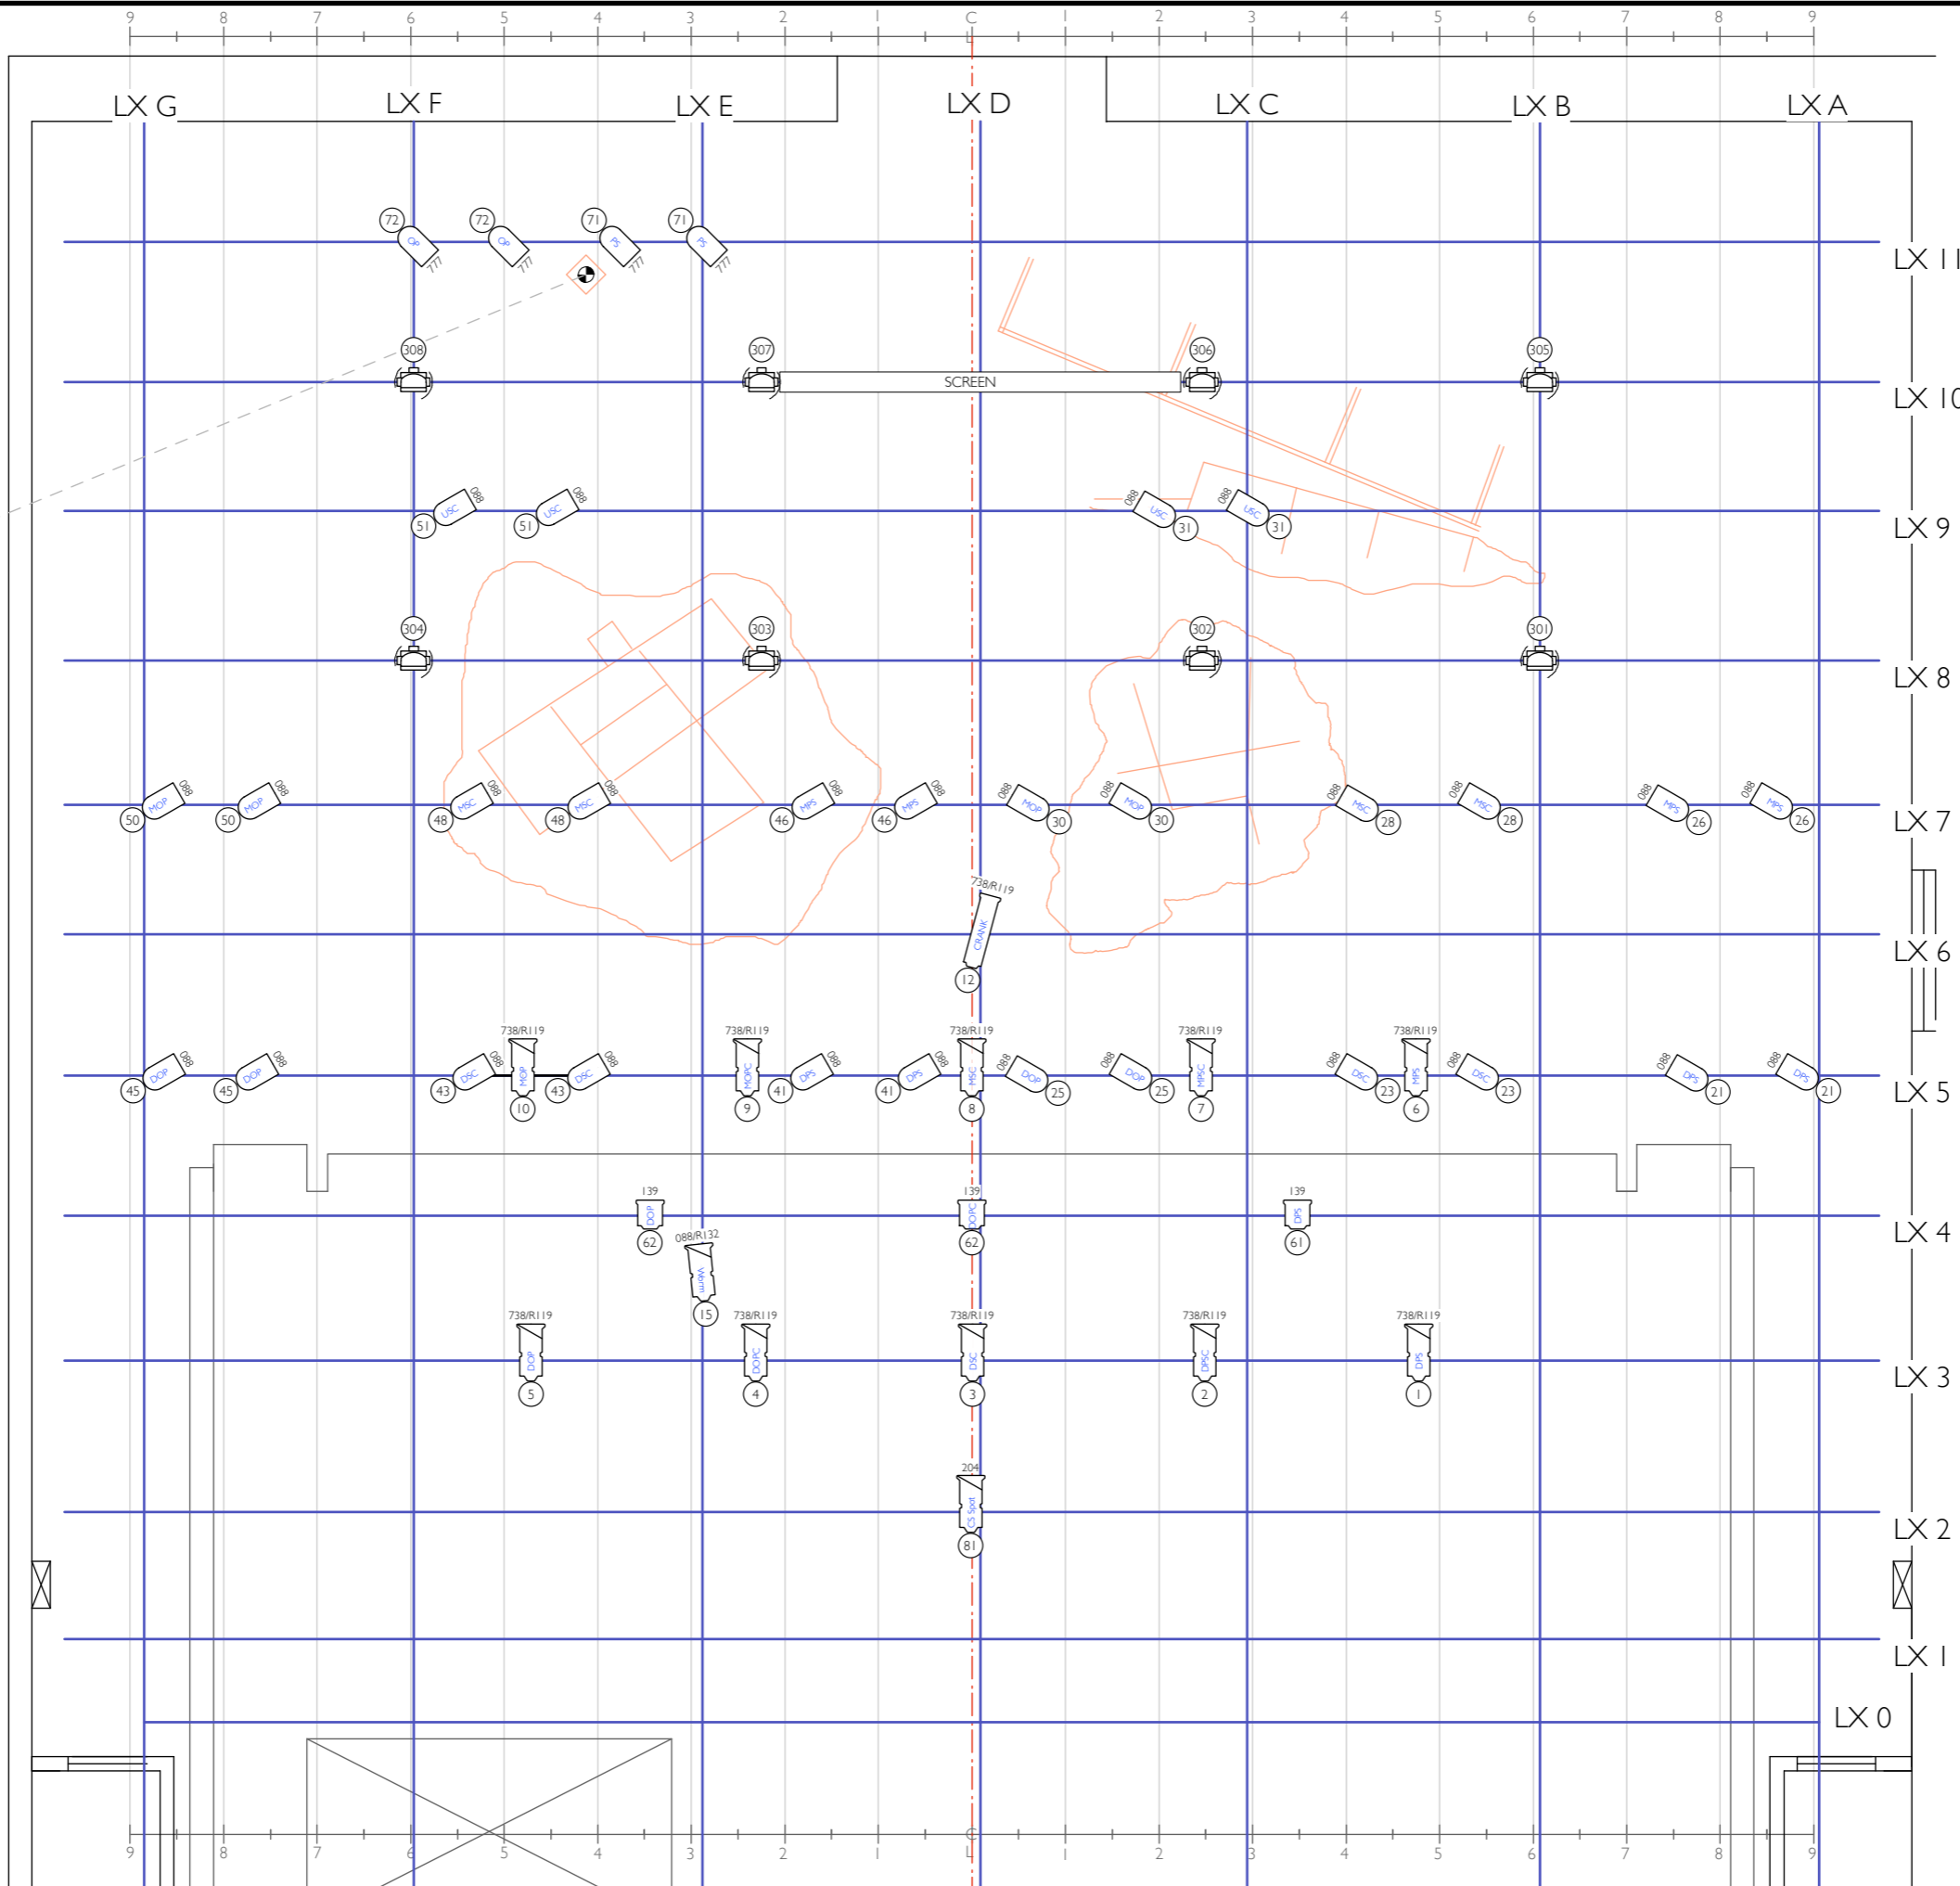

NOTES

- All Fresnels on TRUSS TOWER to be rigged without barndoors.
- All Lamps to be rigged with full colour and accessories.
- All gel is LEE unless otherwise stated.
- Lanterns with same channel # can be patched together, where safe.
- Truss tower lamp measurements from stage floor to centre of LENS.

STANDARD HOUSE LX
Channel 220
STANDARD AISLE LX
Channel 521
PROJECTOR SHUTTER
Channel 240

HERE WE ALL ARE.ASSEMBLED.

JUTE Theatre/ Access Arts Festival 2017

LIGHTING PLAN

03/10/2017-VER 1.0

BILLE BROWN STUDIO 1:75 @ A3

DRAWN BY J.G. © JASON GLENWRIGHT

PRODUCTION TEAM
director MATT SCHOLTEN
designers SIMONA COSENTINI & SIMONETSORIERI
lighting designer JASON GLENWRIGHT

